

INDEX OF PLANS

SHEET No.	DESCRIPTION
1	TITLE AND LOCATION MAP
2	LOCATIONS OF CONSTRUCTION
3-14	TYPICAL CROSS SECTIONS
15-20	KEY MAP AND LINE INDEX
21-28	PROJECT CONTROL PLANS
29-80	LAYOUTS
81-110	CONSTRUCTION DETAILS
111-152	TEMPORARY WATER POLLUTION CONTROL PLANS AND QUANTITIES
153-215	DRAINAGE PLANS, PROFILES, DETAILS AND QUANTITIES
216-379	UTILITY PLANS
380-454	CONSTRUCTION AREA SIGNS
455-511	STAGE CONSTRUCTION AND TRAFFIC HANDLING PLANS AND QUANTITIES
512-513	TRAFFIC HANDLING DETAILS AND QUANTITIES
514-574	PAVEMENT DELINEATION PLANS AND QUANTITIES
575-672	SIGN PLANS, DETAILS, SPECIAL DESIGN SIGNS AND QUANTITIES
673-679	SUMMARY OF QUANTITIES
680-716	RETAINING WALL PLANS
717-730	IRRIGATION PLANS, DETAILS AND QUANTITIES
731-767	EROSION CONTROL LEGEND, PLANS AND QUANTITIES
768-1212	ELECTRICAL PLANS, DETAILS, QUANTITIES AND SPECIAL ELECTRICAL STRUCTURES
1213-1216	REVISED STANDARD PLANS
1217-1238	VENDOR DRAWINGS

STRUCTURE PLANS

1239-1258	RETAINING WALL 24A - SOIL NAIL WALL
1259-1274	RETAINING WALL 24B - SOIL NAIL WALL
1275-1293	RETAINING WALL 26A - RETAINING WALL AND SOUND WALL
1294-1308	RETAINING WALL 29A - SOIL NAIL WALL
1309-1327	RETAINING WALL 29B - SOIL NAIL WALL

THE STANDARD PLANS LIST APPLICABLE TO THIS CONTRACT IS INCLUDED IN THE NOTICE TO BIDDERS AND SPECIAL PROVISIONS BOOK.

STATE OF CALIFORNIA

ACIM-000C(568)E

DEPARTMENT OF TRANSPORTATION




 
 
PROJECT PLANS FOR CONSTRUCTION ON

STATE HIGHWAY

IN ALAMEDA, CONTRA COSTA AND SOLANO COUNTIES

AT VARIOUS LOCATIONS

TO BE SUPPLEMENTED BY STANDARD PLANS DATED 2024

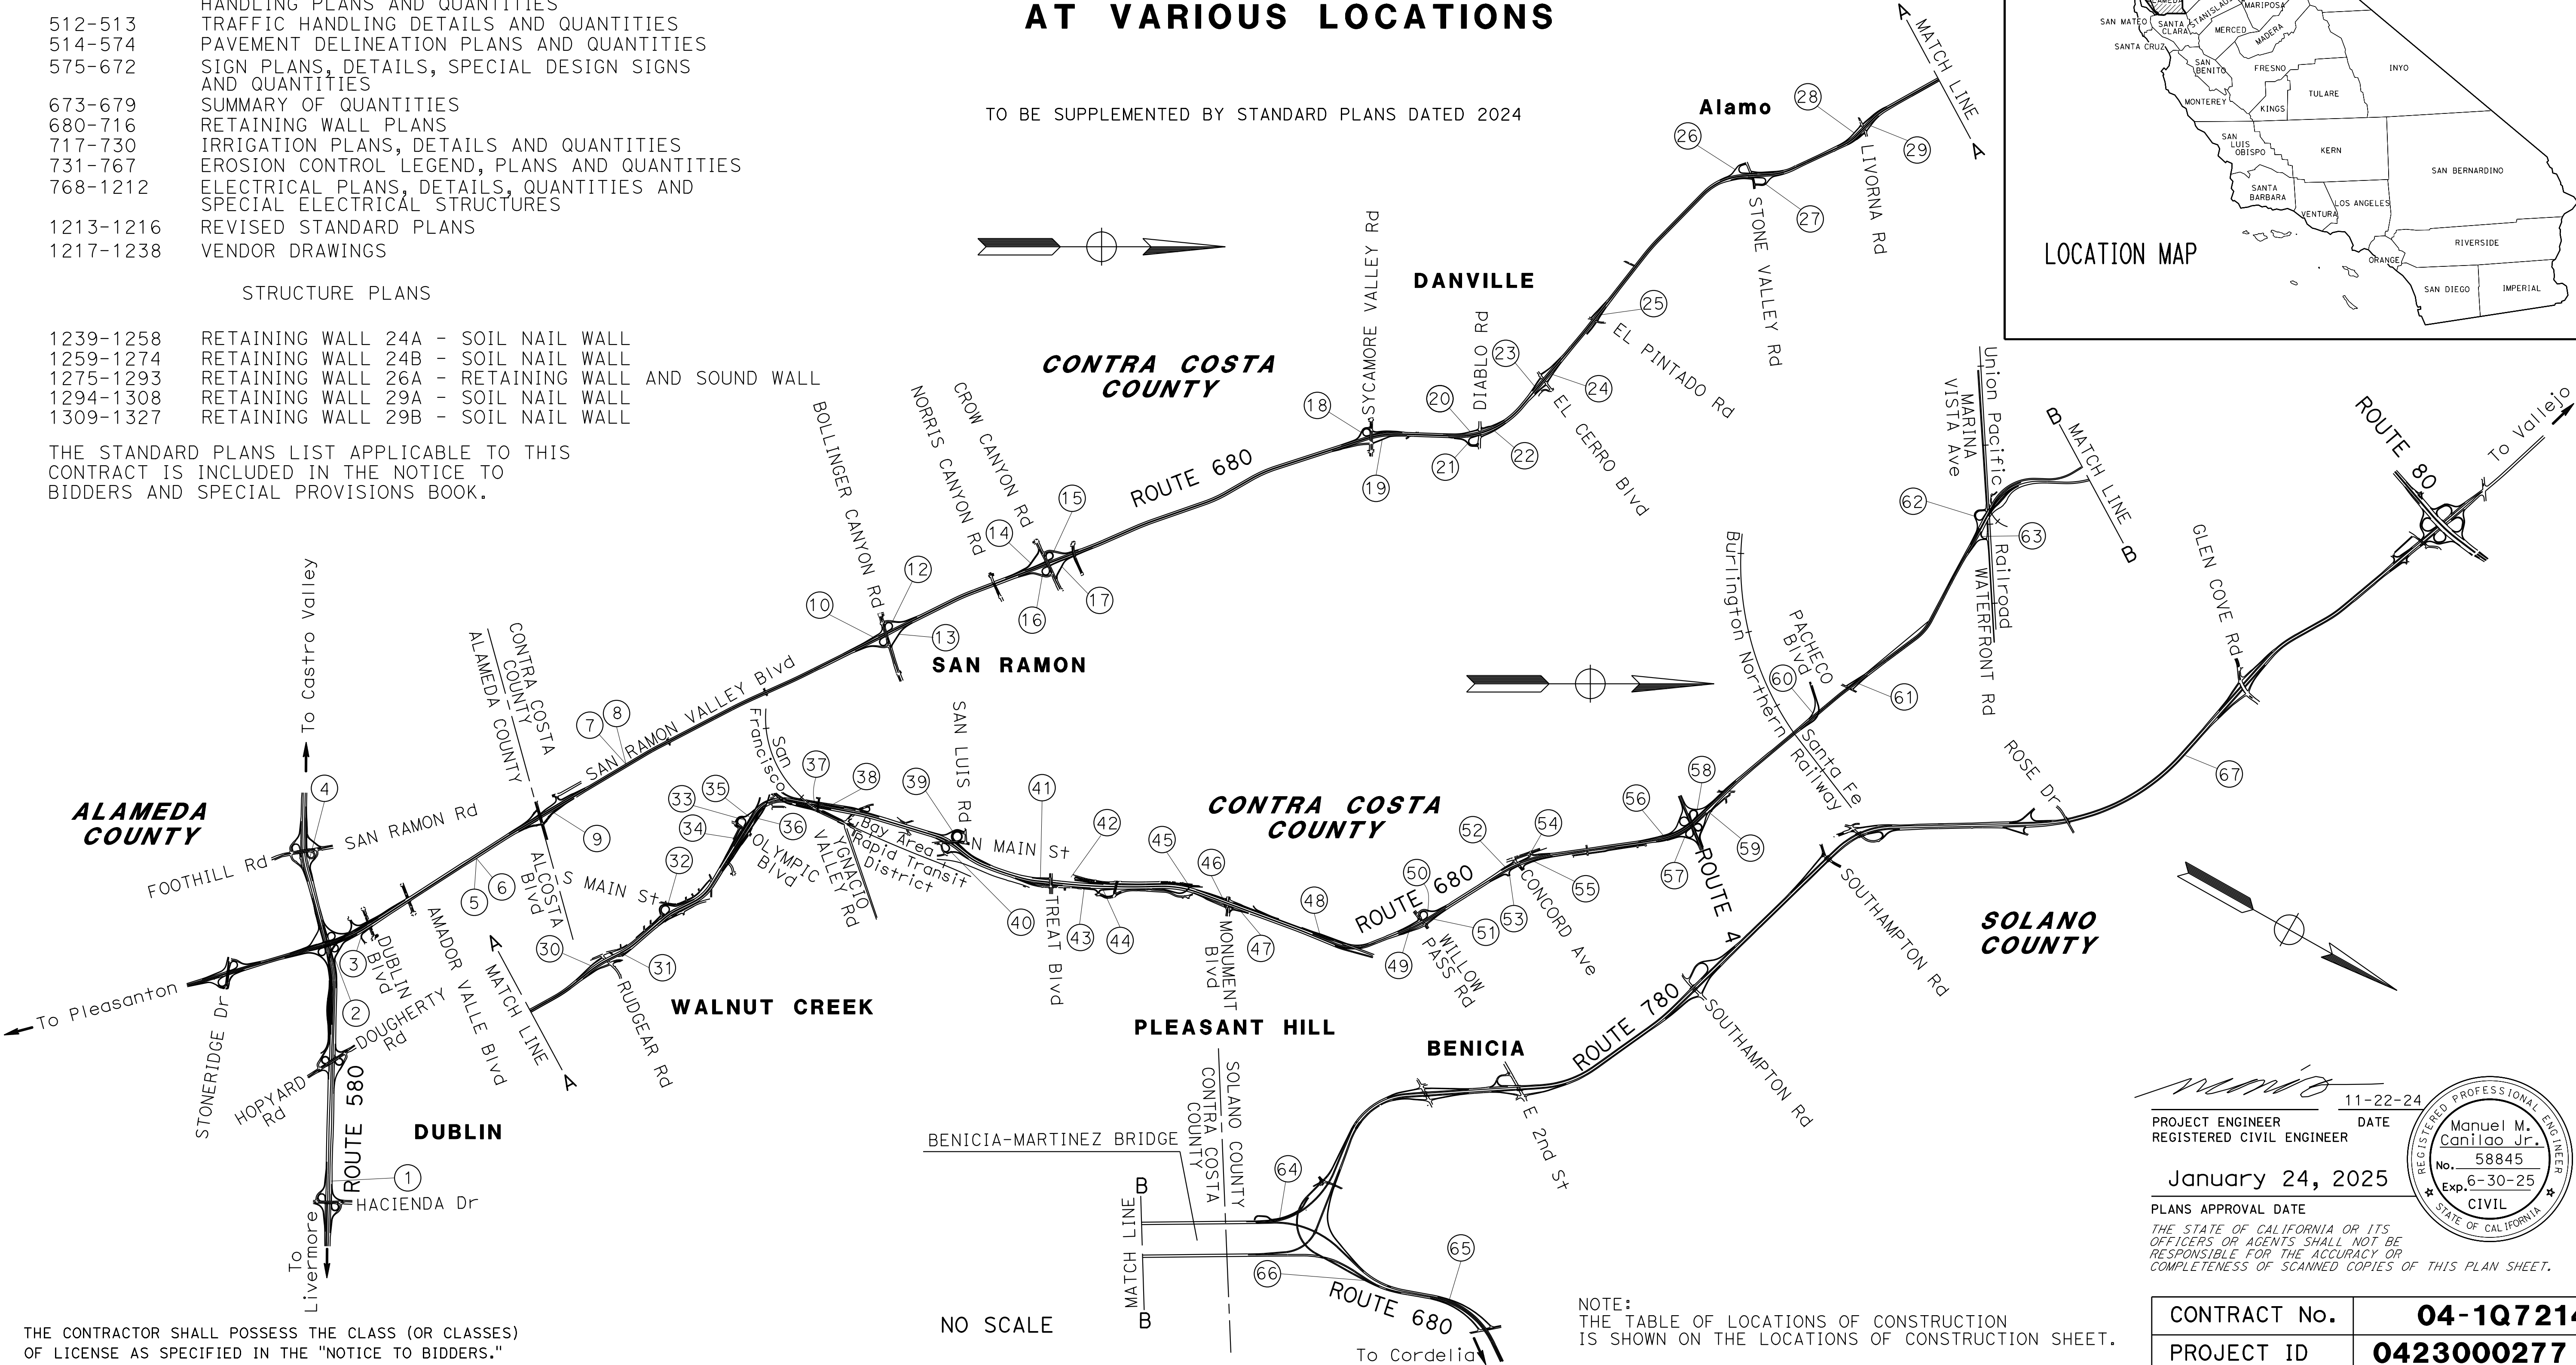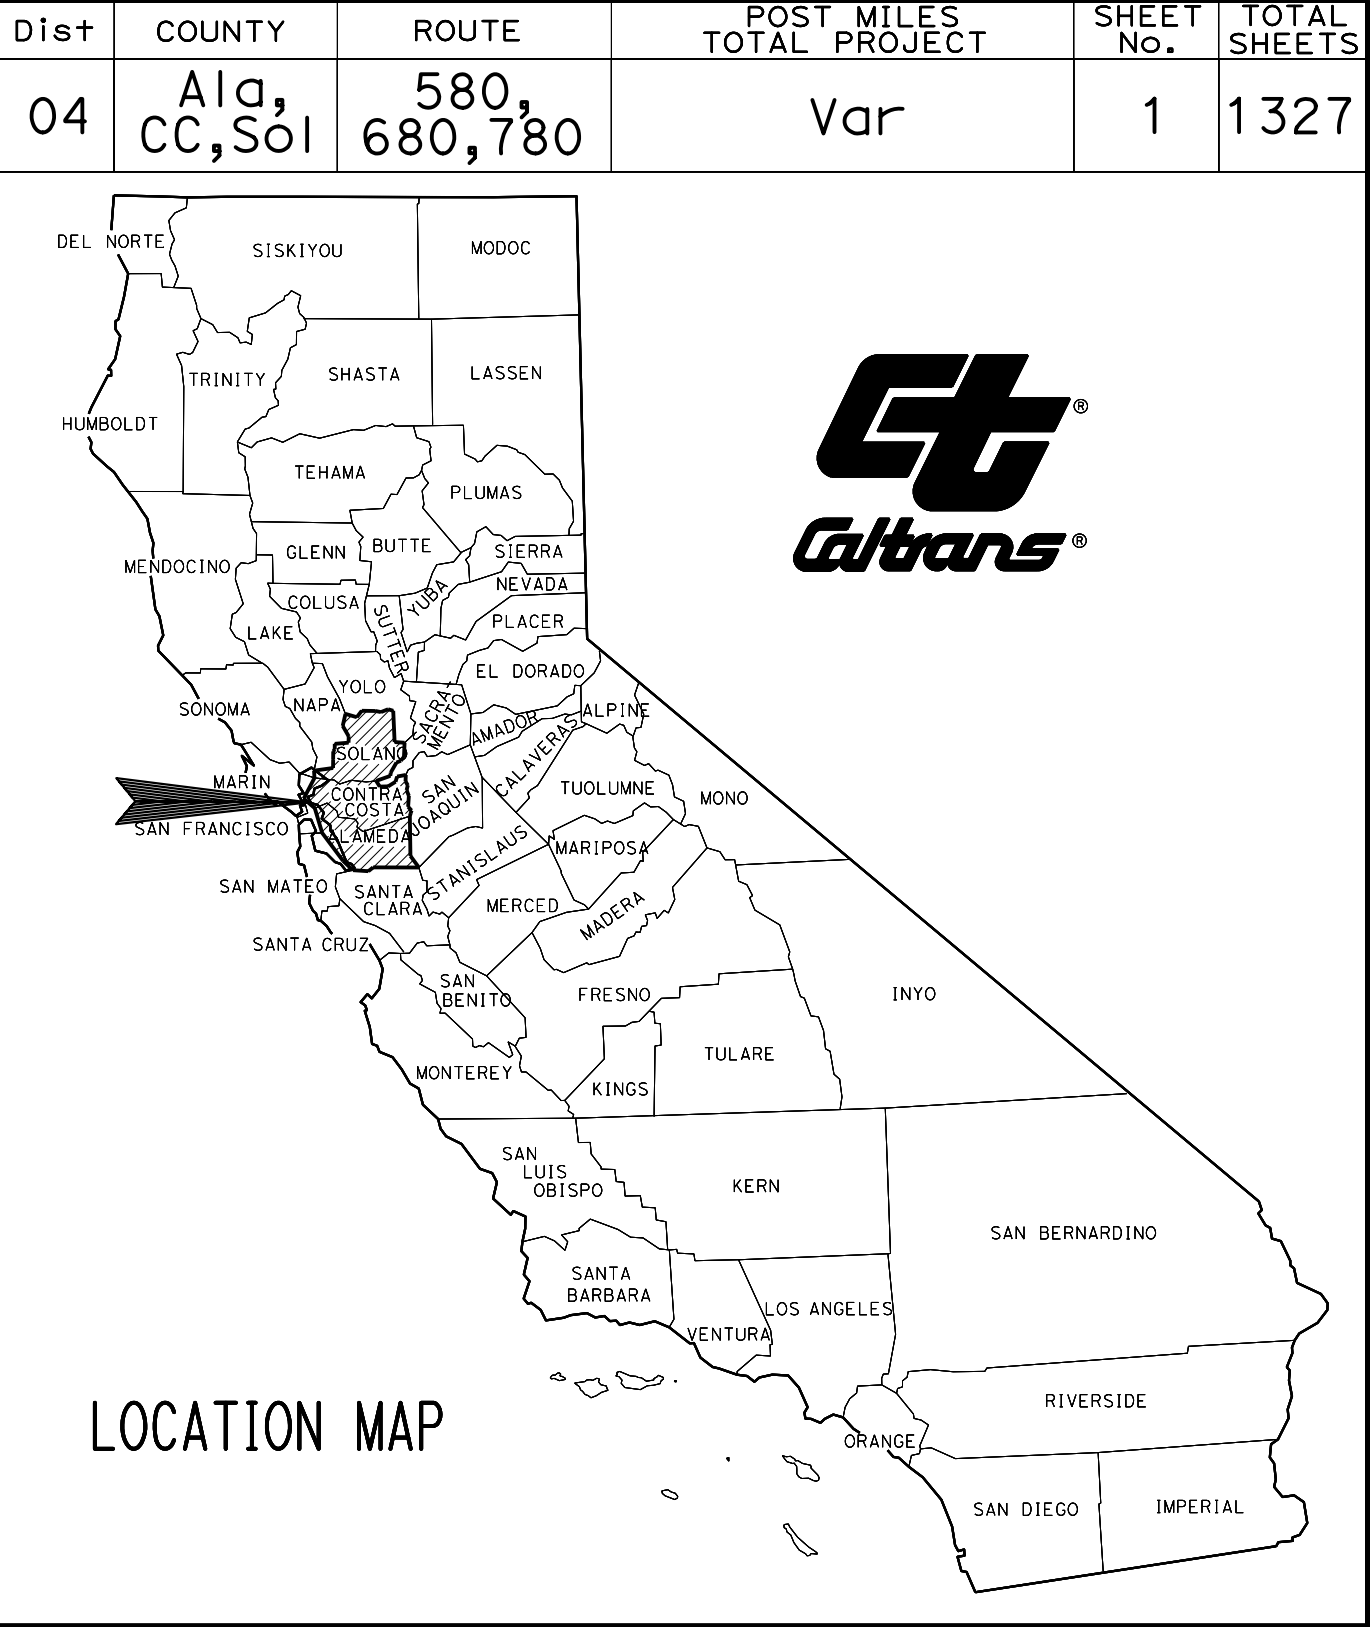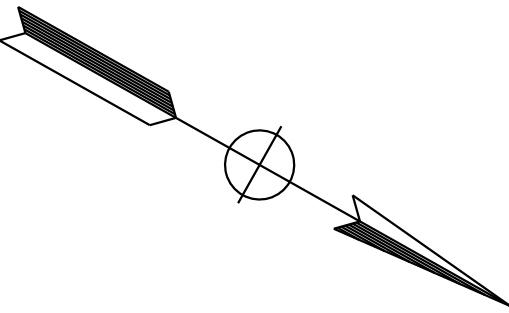

NO SCALE

NOTE:
THE TABLE OF LOCATIONS OF CONSTRUCTION IS SHOWN ON THE LOCATIONS OF CONSTRUCTION SHEET.

11-22-24
PROJECT ENGINEER
REGISTERED CIVIL ENGINEER
DATE

Manuel M. Canilao Jr.
No. 58845
Exp. 6-30-25
CIVIL
STATE OF CALIFORNIA

January 24, 2025
PLANS APPROVAL DATE
THE STATE OF CALIFORNIA OR ITS OFFICERS OR AGENTS SHALL NOT BE RESPONSIBLE FOR THE ACCURACY OR COMPLETENESS OF SCANNED COPIES OF THIS PLAN SHEET.

CONTRACT No.	04-1Q7214
PROJECT ID	0423000277

LOCATIONS OF CONSTRUCTION

Loc No. ⑥	COUNTY	ROUTE	PM	DESCRIPTION	DIRECTION
①	Ala	580	19.28	WB ON-RAMP FROM HACIENDA Dr	WB
②	Ala	580	20.46	WB ROUTE 580 TO NB ROUTE 680 CONNECTOR	WB
③	Ala	680	R20.36	NB ON-RAMP FROM VILLAGE Pkwy	NB
④	Ala	580	21.23	WB MAINLINE & ON-RAMP/OFF-RAMP TO AND FROM SAN RAMON Rd	WB
⑤ & ⑥	Ala	680	R21.40	0.5 MILE SOUTH OF ALCOSTA Blvd OC	NB
⑦ & ⑧	CC	680	R0.77	0.7 MILE NORTH OF ALCOSTA Blvd OC	SB
⑨	CC	680	R0.17	NB ON-RAMP FROM ALCOSTA Blvd	NB
⑩	CC	680	R2.74	SB ON-RAMP FROM EB BOLLINGER	SB
⑪				NOT USED	
⑫	CC	680	R2.94	SB ON-RAMP FROM WB BOLLINGER	SB
⑬				NOT USED	
⑭	CC	680	R3.91	SB ON-RAMP FROM EB CROW CANYON Rd	SB
⑮	CC	680	R4.11	SB ON-RAMP FROM WB CROW CANYON Rd	SB
⑯				NOT USED	
⑰				NOT USED	
⑱	CC	680	R6.70	SB ON-RAMP FROM SYCAMORE VALLEY Rd	SB
⑲				NOT USED	
⑳	CC	680	R7.43	SB ON-RAMP FROM DIABLO Rd	SB
㉑	CC	680	R7.52	NB ON-RAMP FROM EB DIABLO Rd	NB
㉒	CC	680	R7.22	NB ON-RAMP FROM WB DIABLO Rd	NB
㉓	CC	680	R8.06	SB ON-RAMP FROM EL CERRO Blvd	SB
㉔	CC	680	R8.32	NB ON-RAMP FROM EL CERRO Blvd	NB
㉕	CC	680	R8.84	NB ON-RAMP FROM EL PINTADO Rd	NB
㉖	CC	680	R10.21	SB ON-RAMP FROM STONE VALLEY Rd	SB
㉗	CC	680	R10.55	NB ON-RAMP FROM STONE VALLEY Rd	NB
㉘	CC	680	R11.13	SB ON-RAMP FROM LIVORNA Rd	SB
㉙	CC	680	R11.40	NB ON-RAMP FROM LIVORNA Rd	NB
㉚	CC	680	R12.42	SB ON-RAMP FROM RUDGEAR Rd	SB
㉛	CC	680	12.72	NB ON-RAMP FROM DANVILLE Blvd	NB
㉜	CC	680	13.09	SB ON-RAMP FROM SB S MAIN St	SB
㉝	CC	680	13.81	SB ON-RAMP FROM WB OLYMPIC Blvd	SB
㉞	CC	680	13.81	SB ON-RAMP FROM EB OLYMPIC Blvd	SB
㉟				NOT USED	
㊱				NOT USED	

LOCATIONS OF CONSTRUCTION (CONTINUED)

Loc No. ⑥	COUNTY	ROUTE	PM	DESCRIPTION	DIRECTION
⑳	CC	680	14.55	EB ROUTE 24	NB
㉑	CC	680	14.67	SB ON-RAMP FROM HILLSIDE Ave/YGNACIO Blvd	SB
㉒	CC	680	15.5	SB ON-RAMP FROM N MAIN St	SB
㉓	CC	680	15.73	NB ON-RAMP FROM LAWRENCE Wy	NB
㉔	CC	680	16.29	SB ON-RAMP FROM GEARY Rd	SB
㉕	CC	680	16.55	SB ON-RAMP FROM SUNNYVALE Ave	SB
㉖	CC	680	16.7	NB ON-RAMP FROM TREAT Blvd/BUSKIRK Ave	NB
㉗	CC	680	16.85	NB ON-RAMP FROM BUSKIRK Ave/OAK Rd/ELENA Ct	NB
㉘	CC	680	R17.32	SB ON-RAMP FROM CONTRA COSTA Blvd/BOYD Rd	SB
㉙	CC	680	R17.47	SB ON-RAMP FROM MONUMENT Blvd	SB
㉚	CC	680	R17.83	NB ON-RAMP FROM MONUMENT Blvd	NB
㉛	CC	680	R18.44	SB ON-RAMP FROM SB 242	SB
㉜	CC	680	R19.05	SB ON-RAMP FROM EB WILLOW PASS Rd	SB
㉝	CC	680	19.07	SB ON-RAMP FROM WB WILLOW PASS Rd	SB
㉞	CC	680	19.2	NB ON-RAMP FROM WILLOW PASS Rd	NB
㉟	CC	680	19.7	SB ON-RAMP FROM CONCORD Ave	SB
㊱	CC	680	19.84	NB ON-RAMP FROM BURNETT Ave	NB
㊱	CC	680	19.89	SB ON-RAMP FROM CONTRA COSTA Blvd	SB
㊱	CC	680	20.04	NB ON-RAMP FROM CONCORD Ave	NB
㊱				NOT USED	
㊱				NOT USED	
㊱				NOT USED	
㊱				NOT USED	
㊱	CC	680	22.36	SB ON-RAMP FROM PACHECO Blvd	SB
㊱	CC	680	22.83	NB ON-RAMP FROM ARTHUR Rd	NB
㊱	CC	680	24.25	SB ON-RAMP FROM MARINA VISTA Ave	SB
㊱	CC	680	24.31	NB ON-RAMP FROM WATERFRONT Rd	NB
㊱	SOL	780	0.14L/0.50L	0.1 MILE SOUTH OF JUNCTION WB ROUTE 780/SB ROUTE 680	SB
㊱	SOL	680	R0.83	SB ON-RAMP FROM BAYSHORE Rd	SB
㊱	SOL	680	0.61L	EB ROUTE 780 OFF-RAMP TO NB ROUTE 680	NB
㊱	SOL	780	5.57	WB ROUTE 780, 0.4 MILE EAST OF GLEN COVE Rd OC	WB

LOCATIONS OF CONSTRUCTION