


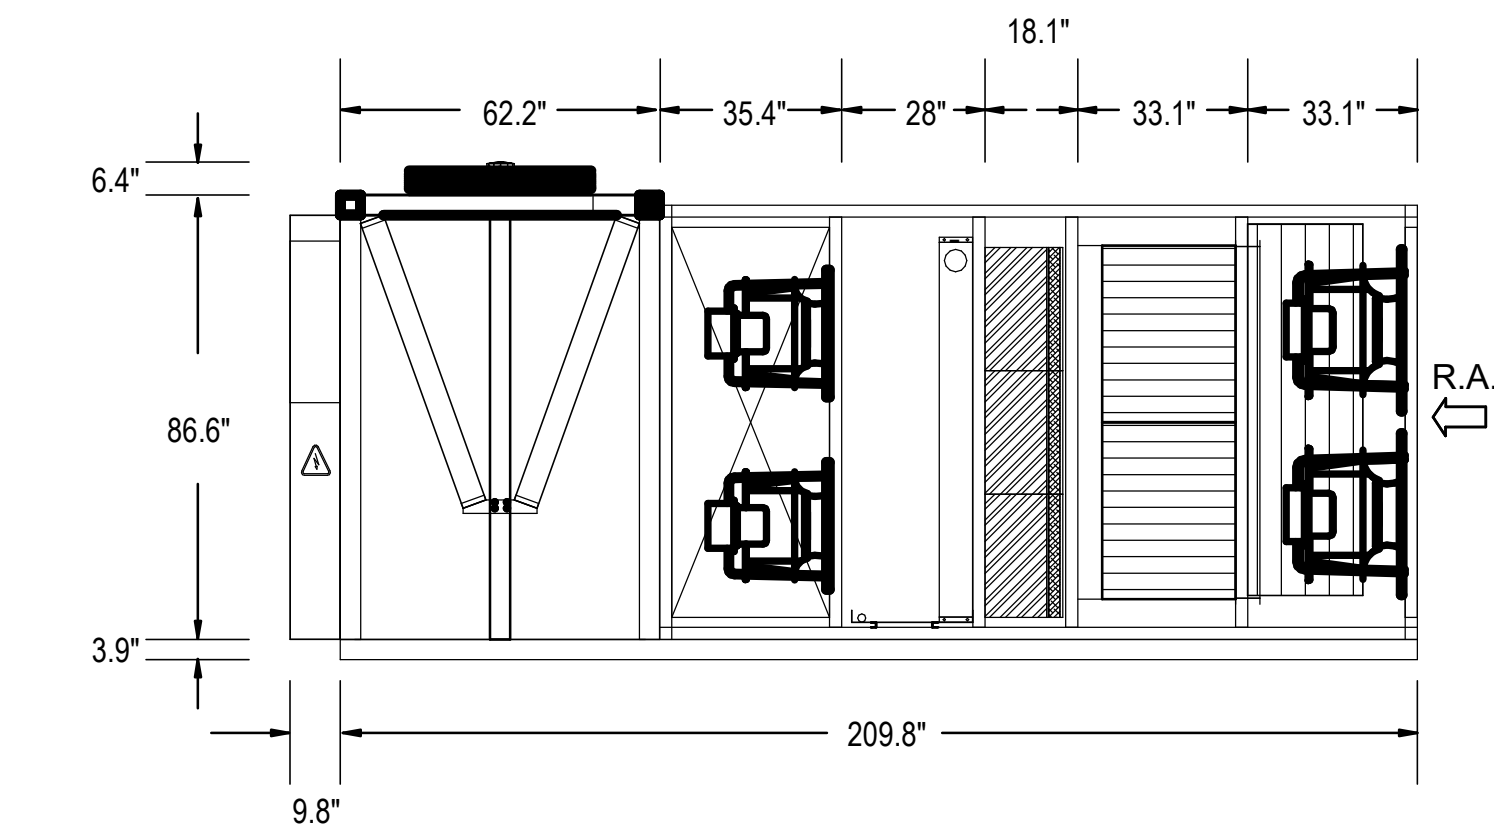
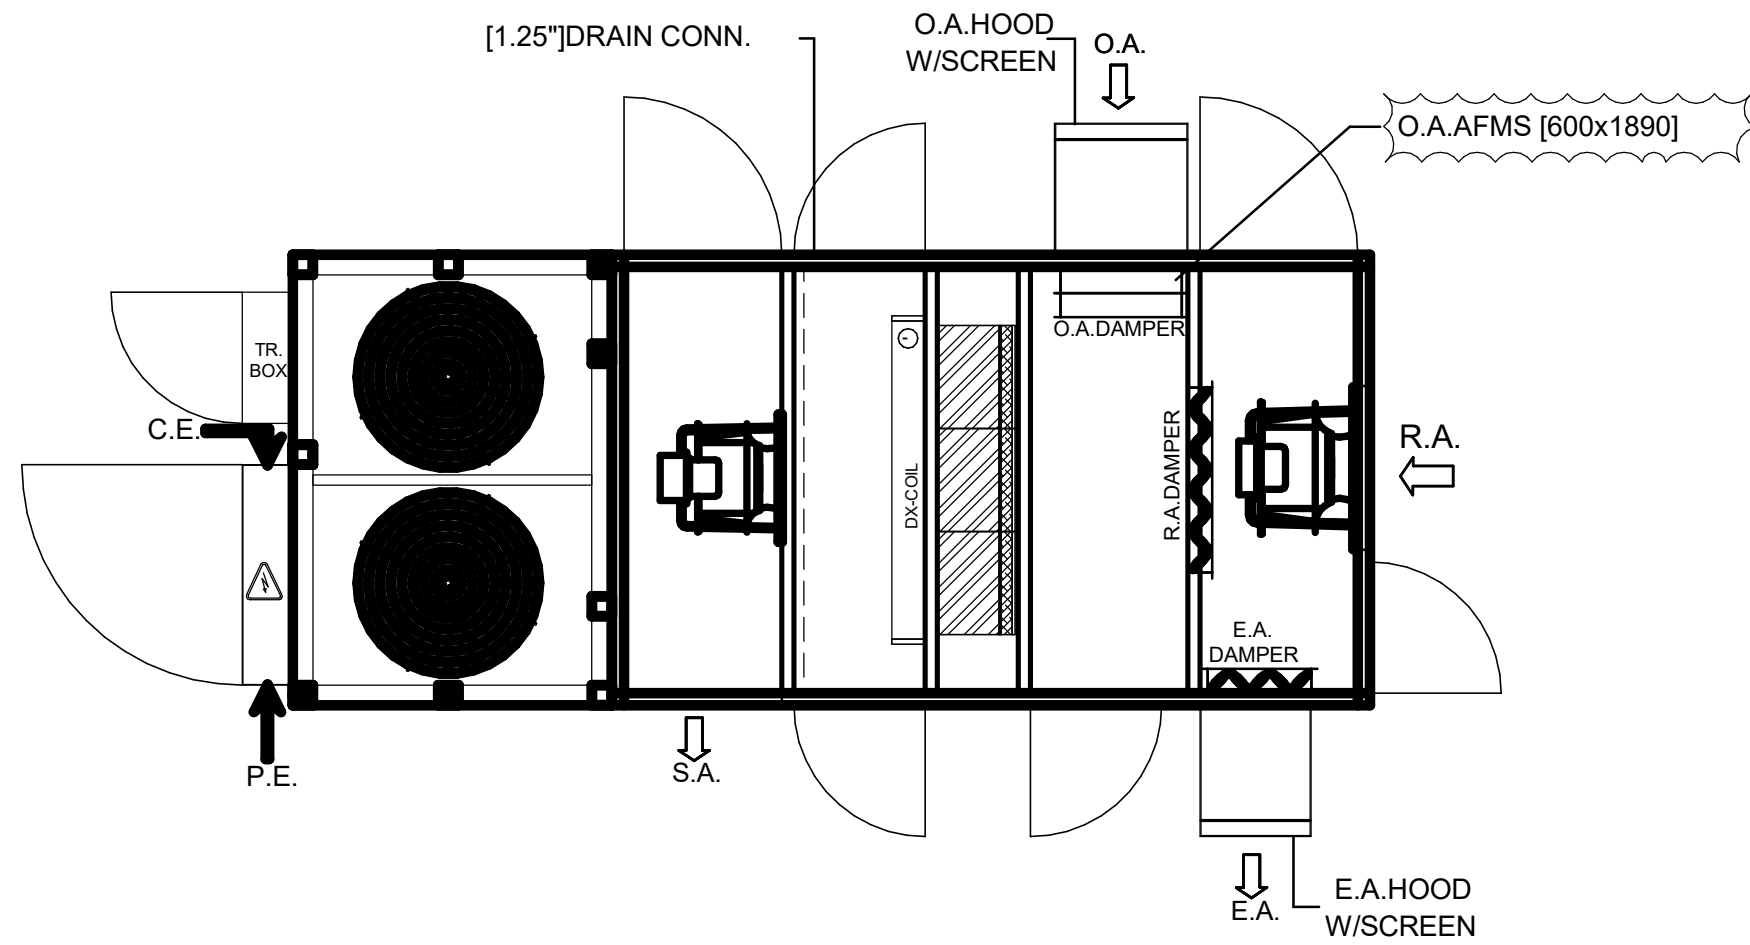


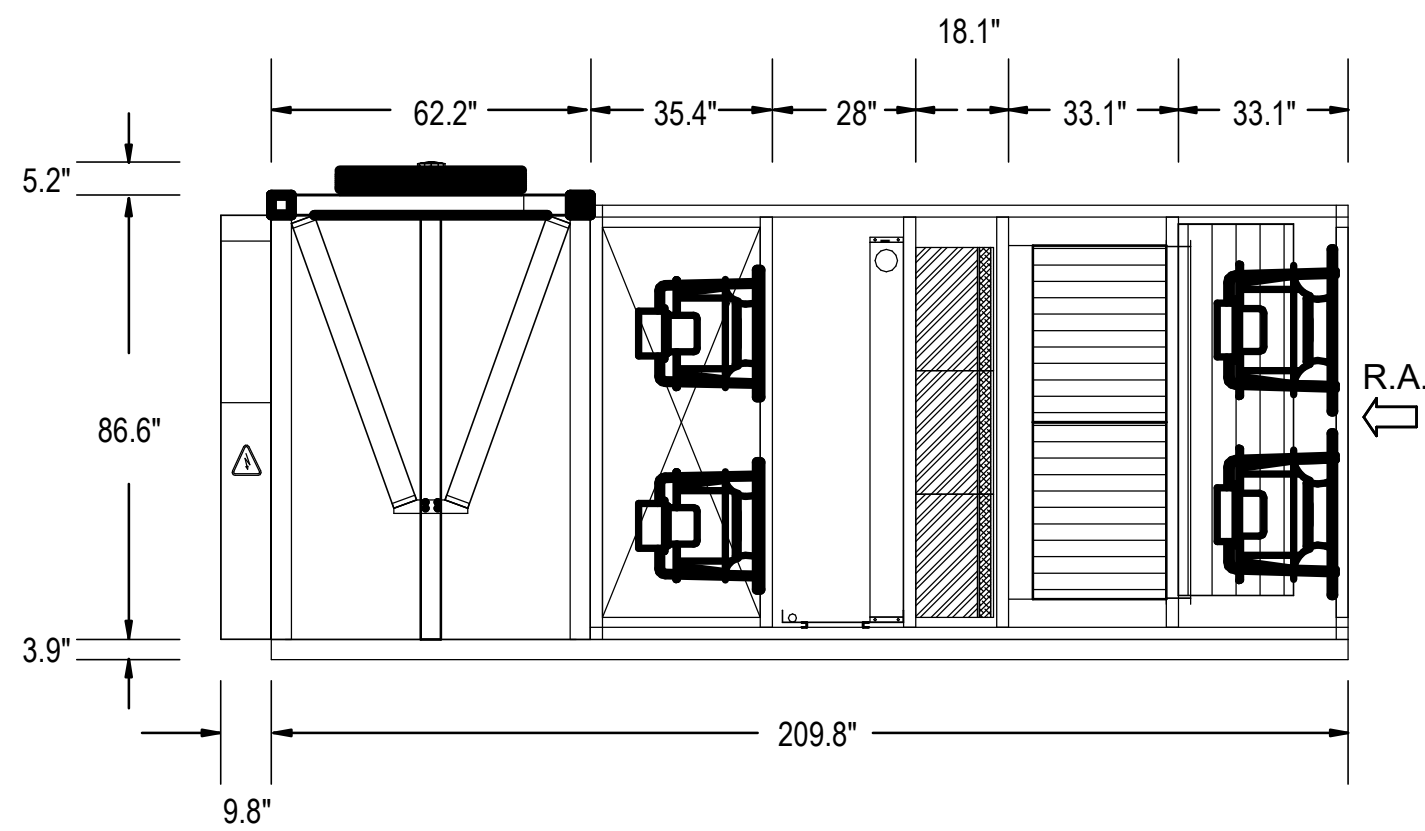


5 AC-1,2,3 DETAIL
SCALE: NONE

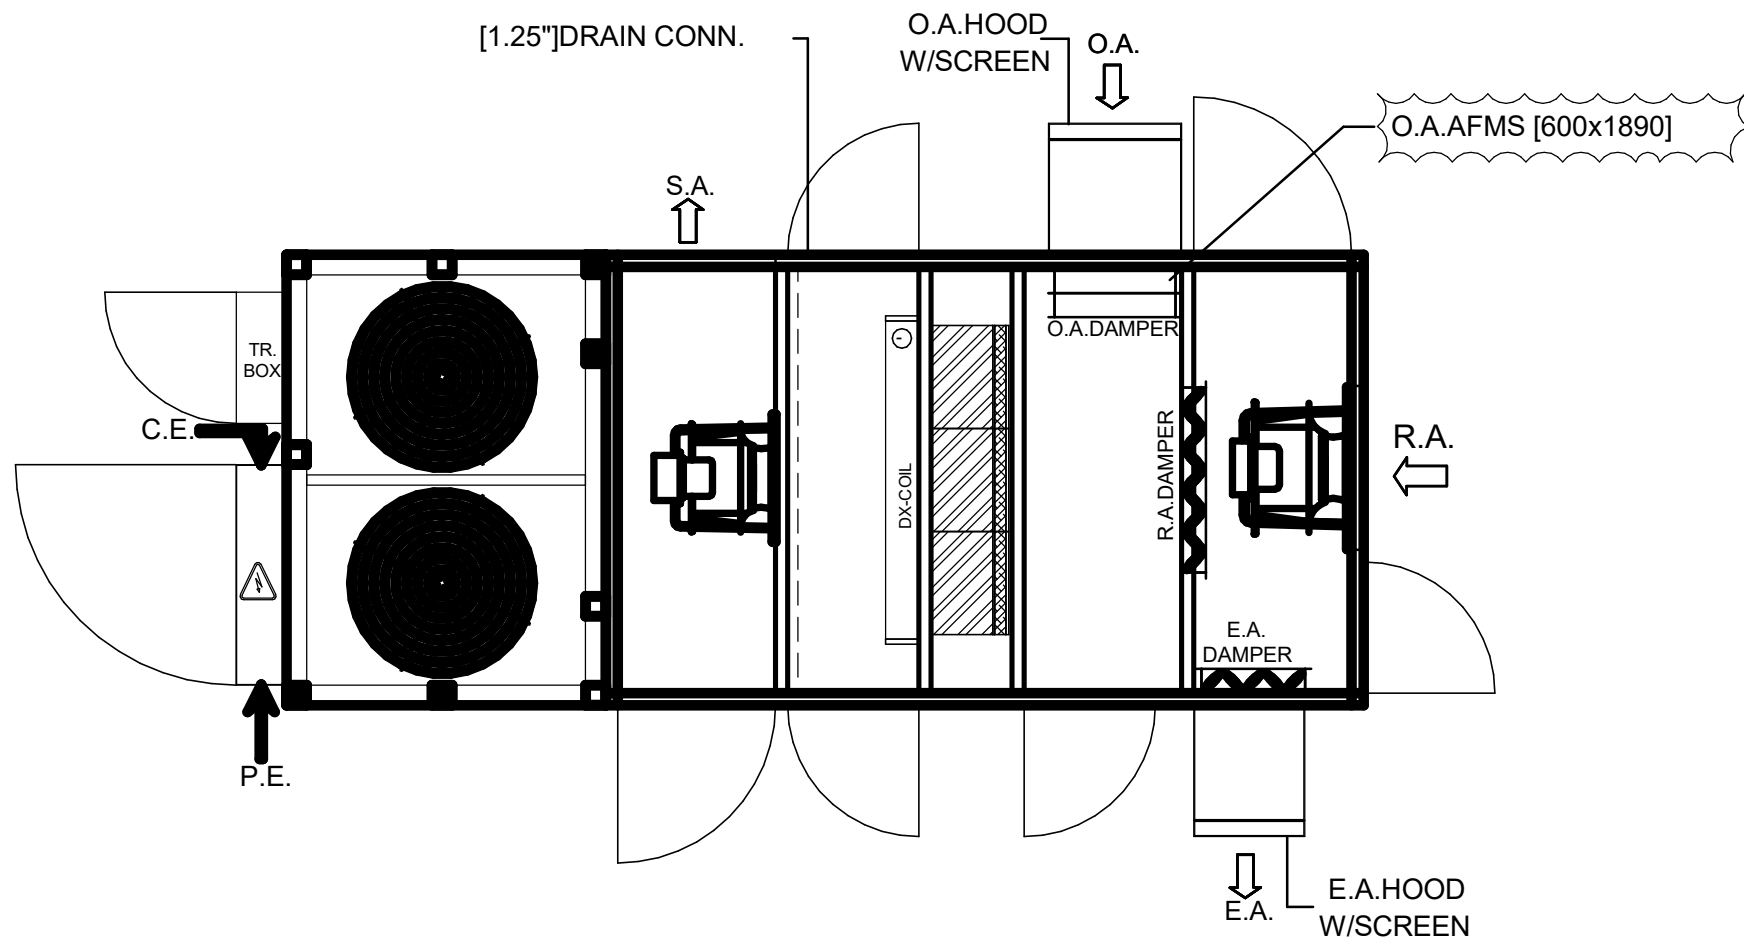


4 AC-4 DETAIL
SCALE: NONE

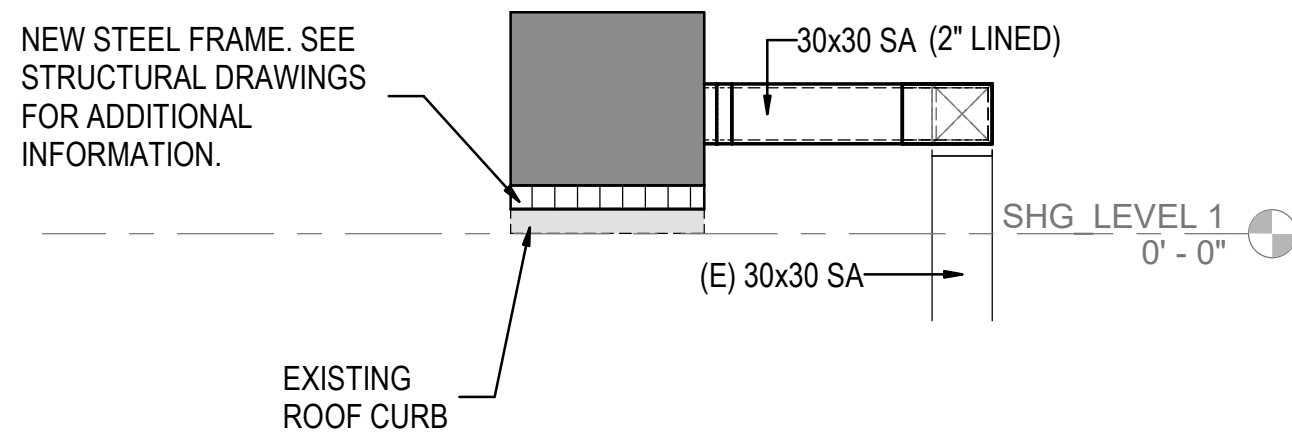

1 AC SECTION VIEW - NORTH SOUTH
SCALE: 1/8" = 1'-0"

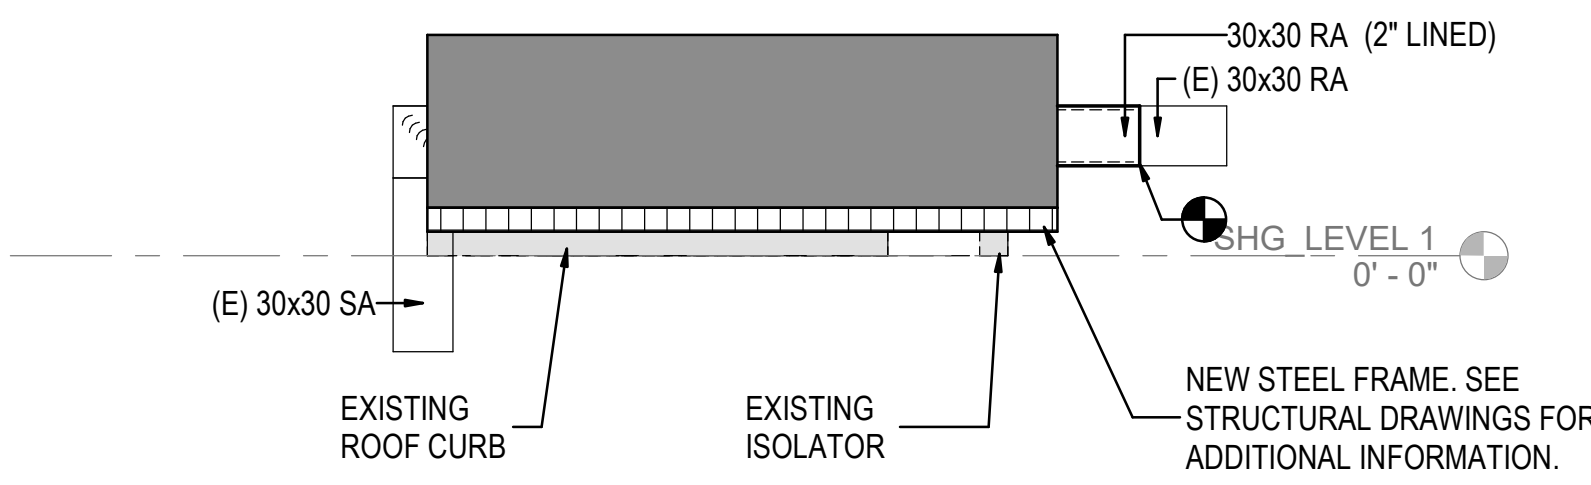


2 AC SECTION VIEW - EAST WEST
SCALE: 1/8" = 1'-0"

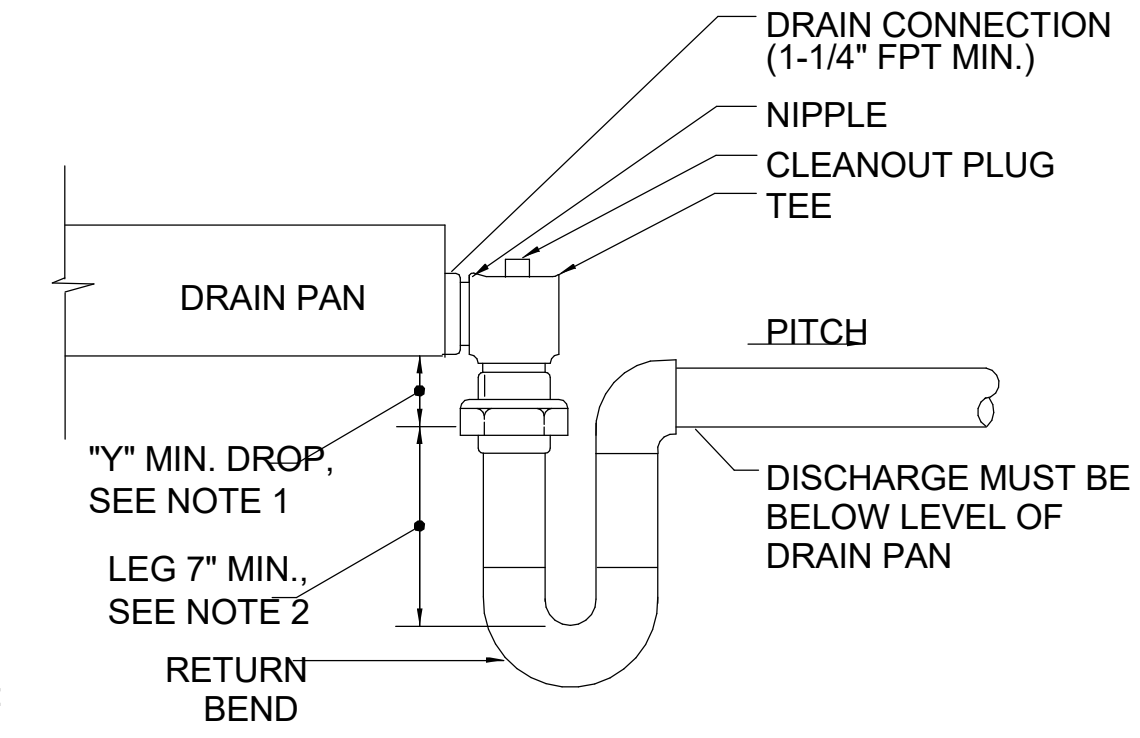


- NOTES:
- 1" MIN DROP REQUIRED. USE OF STANDARD FITTINGS SHOWN EXCEEDS THIS MINIMUM.
 - Y + 1" = LEG FOR BLOW THRU UNIT WHERE: Y=DISCHARGE PRESSURE OF FAN.
 - ALLOW SUFFICIENT SPACE BELOW DRAIN PAN FOR TRAP.
 - PITCH DRAIN FOR PROPER RUN-OFF AND DISCHARGE TO APPROVED RECEPTOR.
 - SUPPORT LENGTHY DRAIN LINES TO PREVENT SAG AND CONDENSATE OVERFLOW.
 - MANUALLY PRIME FILL TRAP BEFORE START-UP TO FORM INITIAL DRAIN SEAL.


1 DRAIN PAN WATER SEAL PIPING - ELBOW THRU UNIT
SCALE: NONE

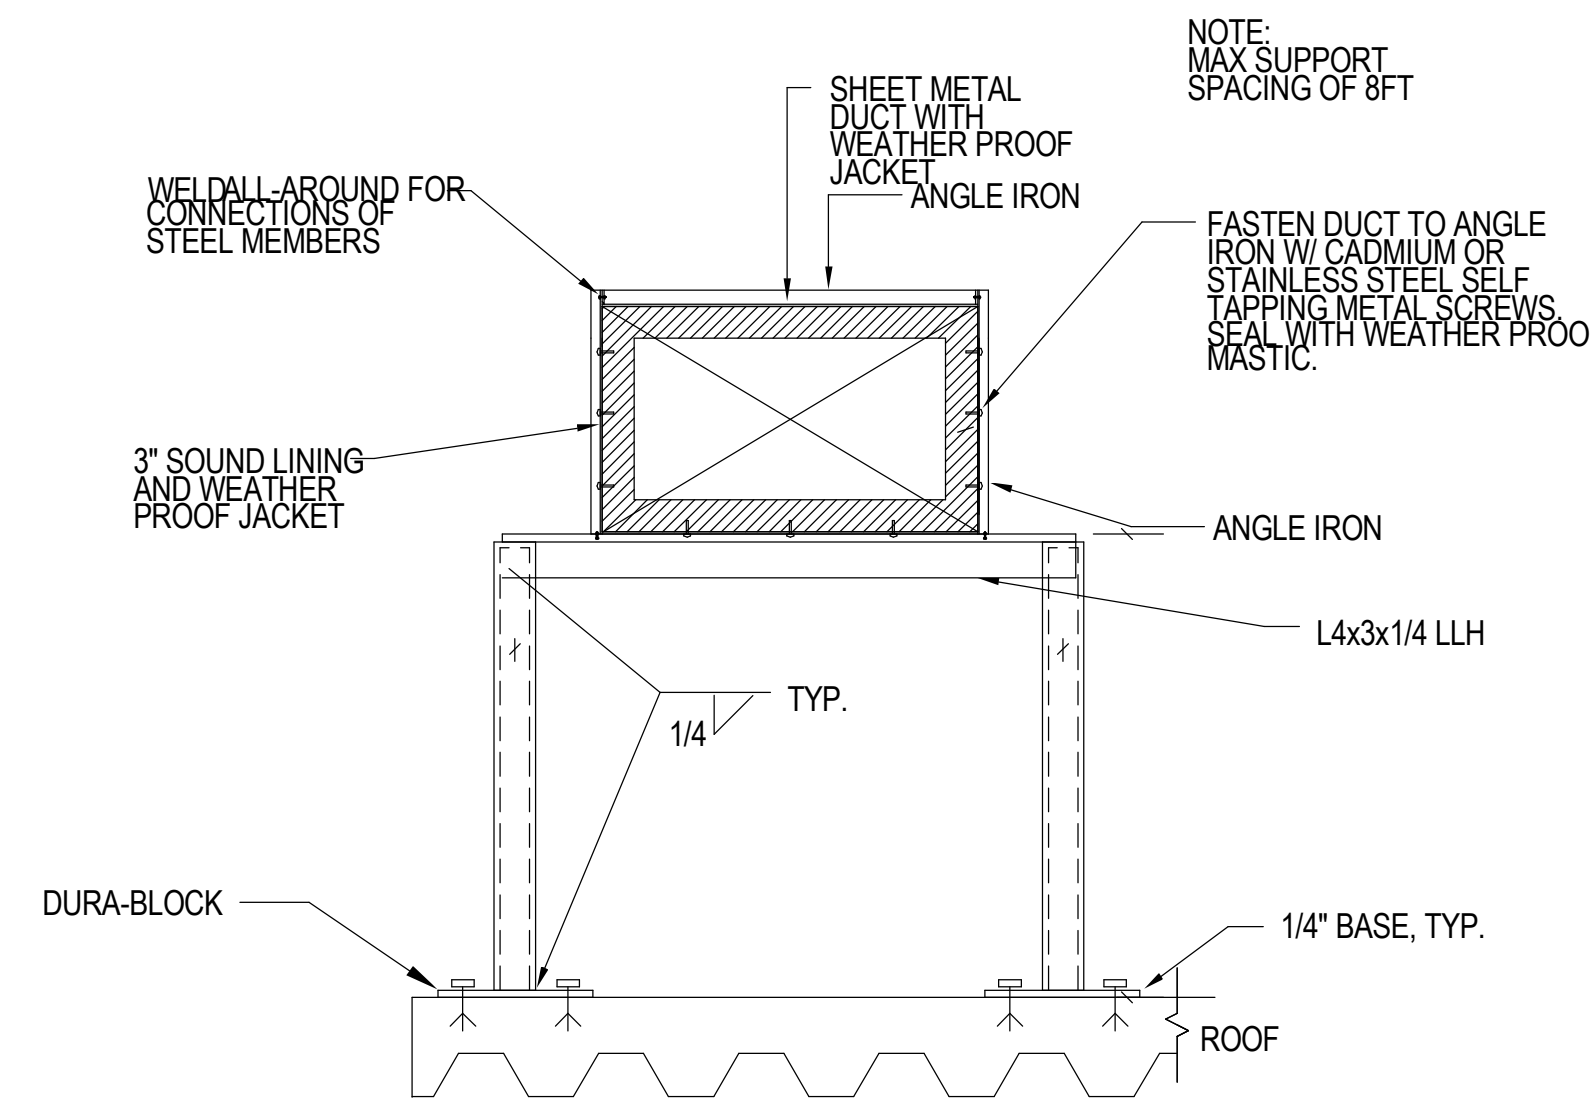

2 DUCT ROOF MOUNTED SUPPORT DETAIL
SCALE: NONE

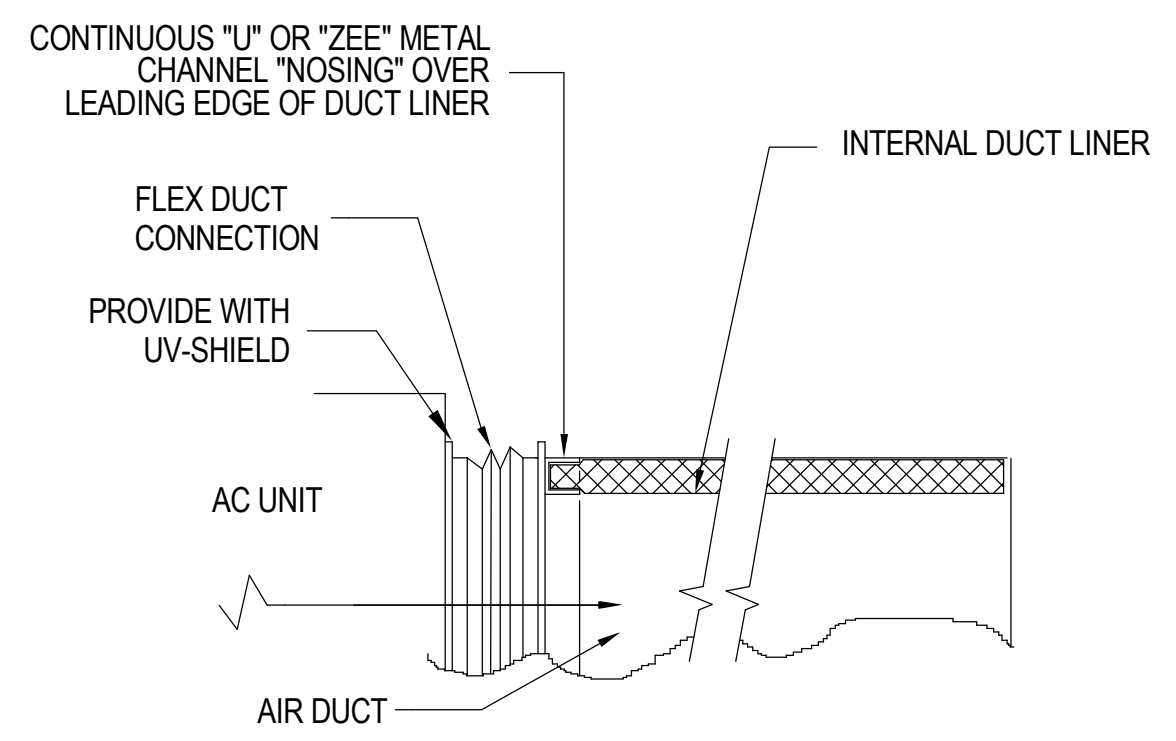

3 DUCT CONNECTOR DETAIL
SCALE: NONE

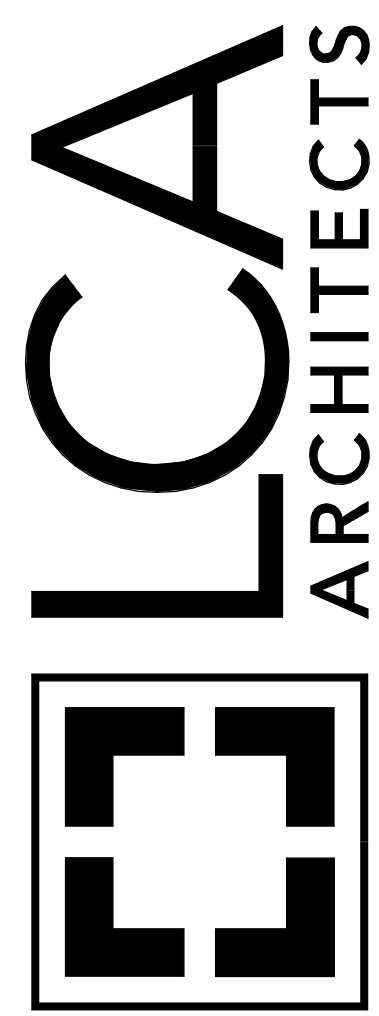

WWW.LCA-ARCHITECTS.COM
CARL E. CAMPOS
DAVID BOGSTAD
550 YGNACIO VALLEY ROAD, SUITE 310
WALNUT CREEK, CALIFORNIA 94596
(925) 944-1626
1970 BROADWAY, SUITE 800
OAKLAND, CALIFORNIA 94612
(510) 272-1060

SYSKA HENNESSY GROUP
A member company of SH Group, Inc.
425 California Street
Suite 400
San Francisco, CA 94104
Tel: 415.288.9060
www.syska.com

ROOFTOP CHILLER REPLACEMENT
151 LINUS PAULING DR.
HERCULES, CA 94547



LCA ARCHITECTS
RESTRICTED ARCHITECTURAL DRAWINGS
THE INFORMATION, PLANS, DESIGNS, NOTES AND ARRANGEMENTS SHOWN ON THIS DRAWING ARE CONFIDENTIAL AND MAY NOT BE REPRODUCED IN WHOLE OR IN PART WITHOUT THE EXPRESSED WRITTEN PERMISSION OF LCA ARCHITECTS. DRAWINGS NOTED AS PRELIMINARY, SCHEMATIC AND/OR CONCEPT CONTAIN INFORMATION THAT IS CONCEPTUAL AND SUBJECT TO VERIFICATION AND/OR CHANGE. THE ARCHITECT MAKES NO CLAIM FOR ACCURACY OF CONCEPTUAL INFORMATION, OR OF INFORMATION SUPPLIED BY OTHERS.

MECHANICAL DETAILS

SCALE: NONE
DATE: 01/15/2024

REVISIONS:

PROJECT NO. 22098.06
M3.0
SHEET OF